


NOTES

- THIS DRAWING IS TO BE READ IN CONJUNCTION WITH ALL ENGINEERS & ARCHITECTS DRAWINGS FIGURED DIMENSIONS ONLY (NOT SCALING) TO BE USED. WHERE A CONFLICT OF INFORMATION EXISTS OR IF IN ANY DOUBT - 'ASK'.
- CONSULTANTS TO BE INFORMED IMMEDIATELY OF ANY DISCREPANCIES BEFORE WORK PROCEEDS.

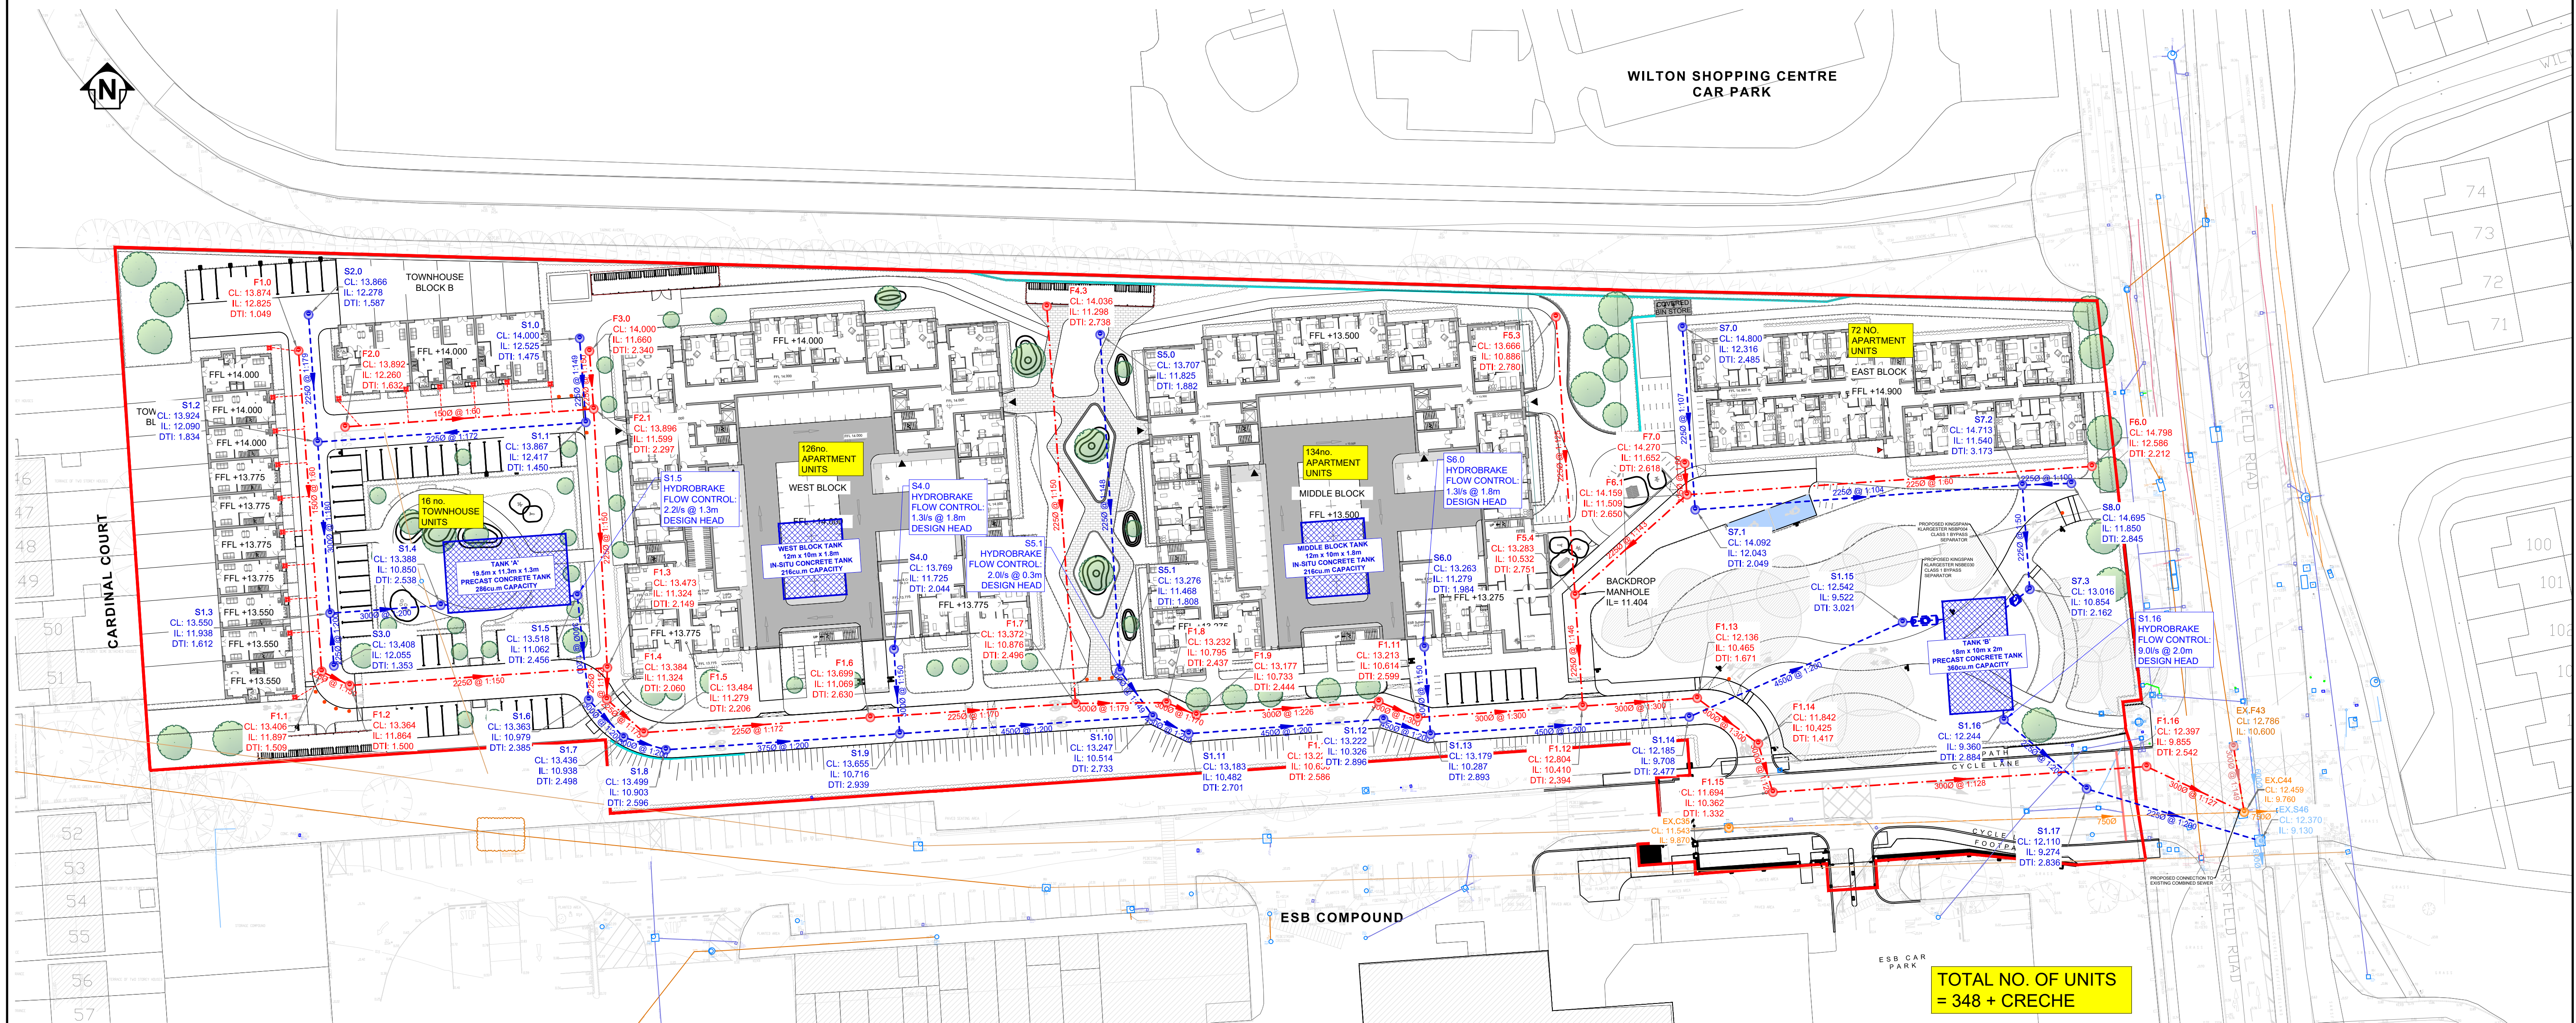

BURIED DRAINAGE PLAN LAYOUT

SCALE @ A1: 1:500
SCALE @ A3: 1:1000


ALL WORKS TO BE CARRIED OUT IN ACCORDANCE WITH UISCE EIREANN CODE OF PRACTICE AND STANDARD DETAILS FOR WASTEWATER INFRASTRUCTURE.

ALL FOUL SEWER PIPES TO BE S_n8 uPVC IN ACCORDANCE WITH UISCE EIREANN WASTEWATER CODE OF PRACTICE.

ROOT BARRIERS SHALL BE USED WHERE FOUL PIPEWORK IS IN CLOSE PROXIMITY TO PROPOSED TREE PLANTING. A TRIPLE COATED, TWIN REINFORCED, IMPERMEABLE, POLYETHYLENE BARRIER MEMBRANE ROOT BARRIER SHALL BE INSTALLED IN THE PIPE TRENCH.

TOTAL NO. OF UNITS
= 348 + CRECHE

DRAINAGE LEGEND

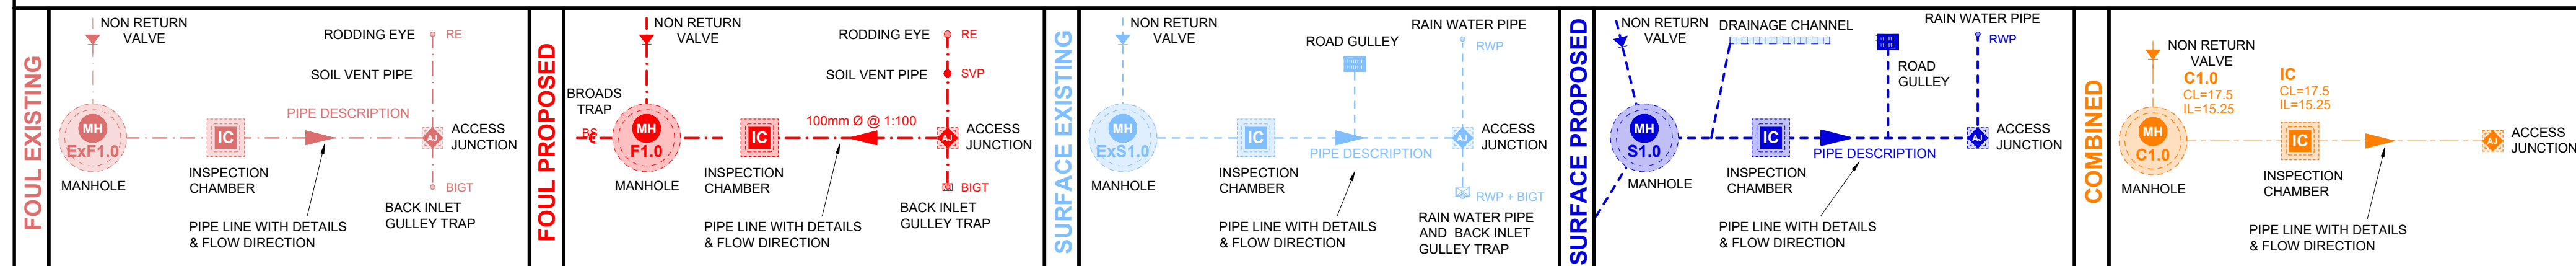

PL4	24.01.25	ISSUED FOR PLANNING	AO
PL4	07.01.25	ISSUED FOR SODA APPLICATION	AO
PL3	11.12.24	ISSUED FOR SODA APPLICATION	AO
PL2	23.09.24	ISSUED FOR SODA APPLICATION	POD
PL1	28.08.24	ISSUED FOR PLANNING	AO

ISSUE	DATE	DESCRIPTION	BY
Project Engineer: Peter O'Dwyer		Project Director: Brian Mahony	

BM STAGE

PLANNING

BM
BARRETT MAHONY
Consulting Engineers, Civil, Structural, Project Management. E-mail: bmce@bmce.ie Web: www.bmce.ie

Dublin Office:
Sandwich House, 52-54 Lower Sandwich Street, Dublin 2, Ireland.
Tel: (01) 677 3200 Fax: (01) 677 3164

London Office:
12 Mill Street, London SE1 2AY, United Kingdom
Tel: (0044) 084 5413 2722

The Institution of Structural Engineers
ACEI
International Federation of Consulting Engineers

CLIENT

LAND DEVELOPMENT AGENCY

PROJECT TITLE

LDA WILTON SARSFIELD ROAD LRD

BM PROJECT No.

23.215

MODEL

REFERENCE

SUITABILITY

REVISION

DRAWING TITLE

BURIED DRAINAGE PLAN LAYOUT

DRAWING REFERENCE

23215-BMD-ZZ-XX-DR-C-11200

STATUS

REVISION

PL4